




New York Institute of Technology  
 NORTHERN BLVD., OLD WESTBURY, NY 11568  
 TEL: 516-686-7659 FAX: 516-686-7921

# Solar Decathlon 2007

CONSTRUCTION DOCUMENTS

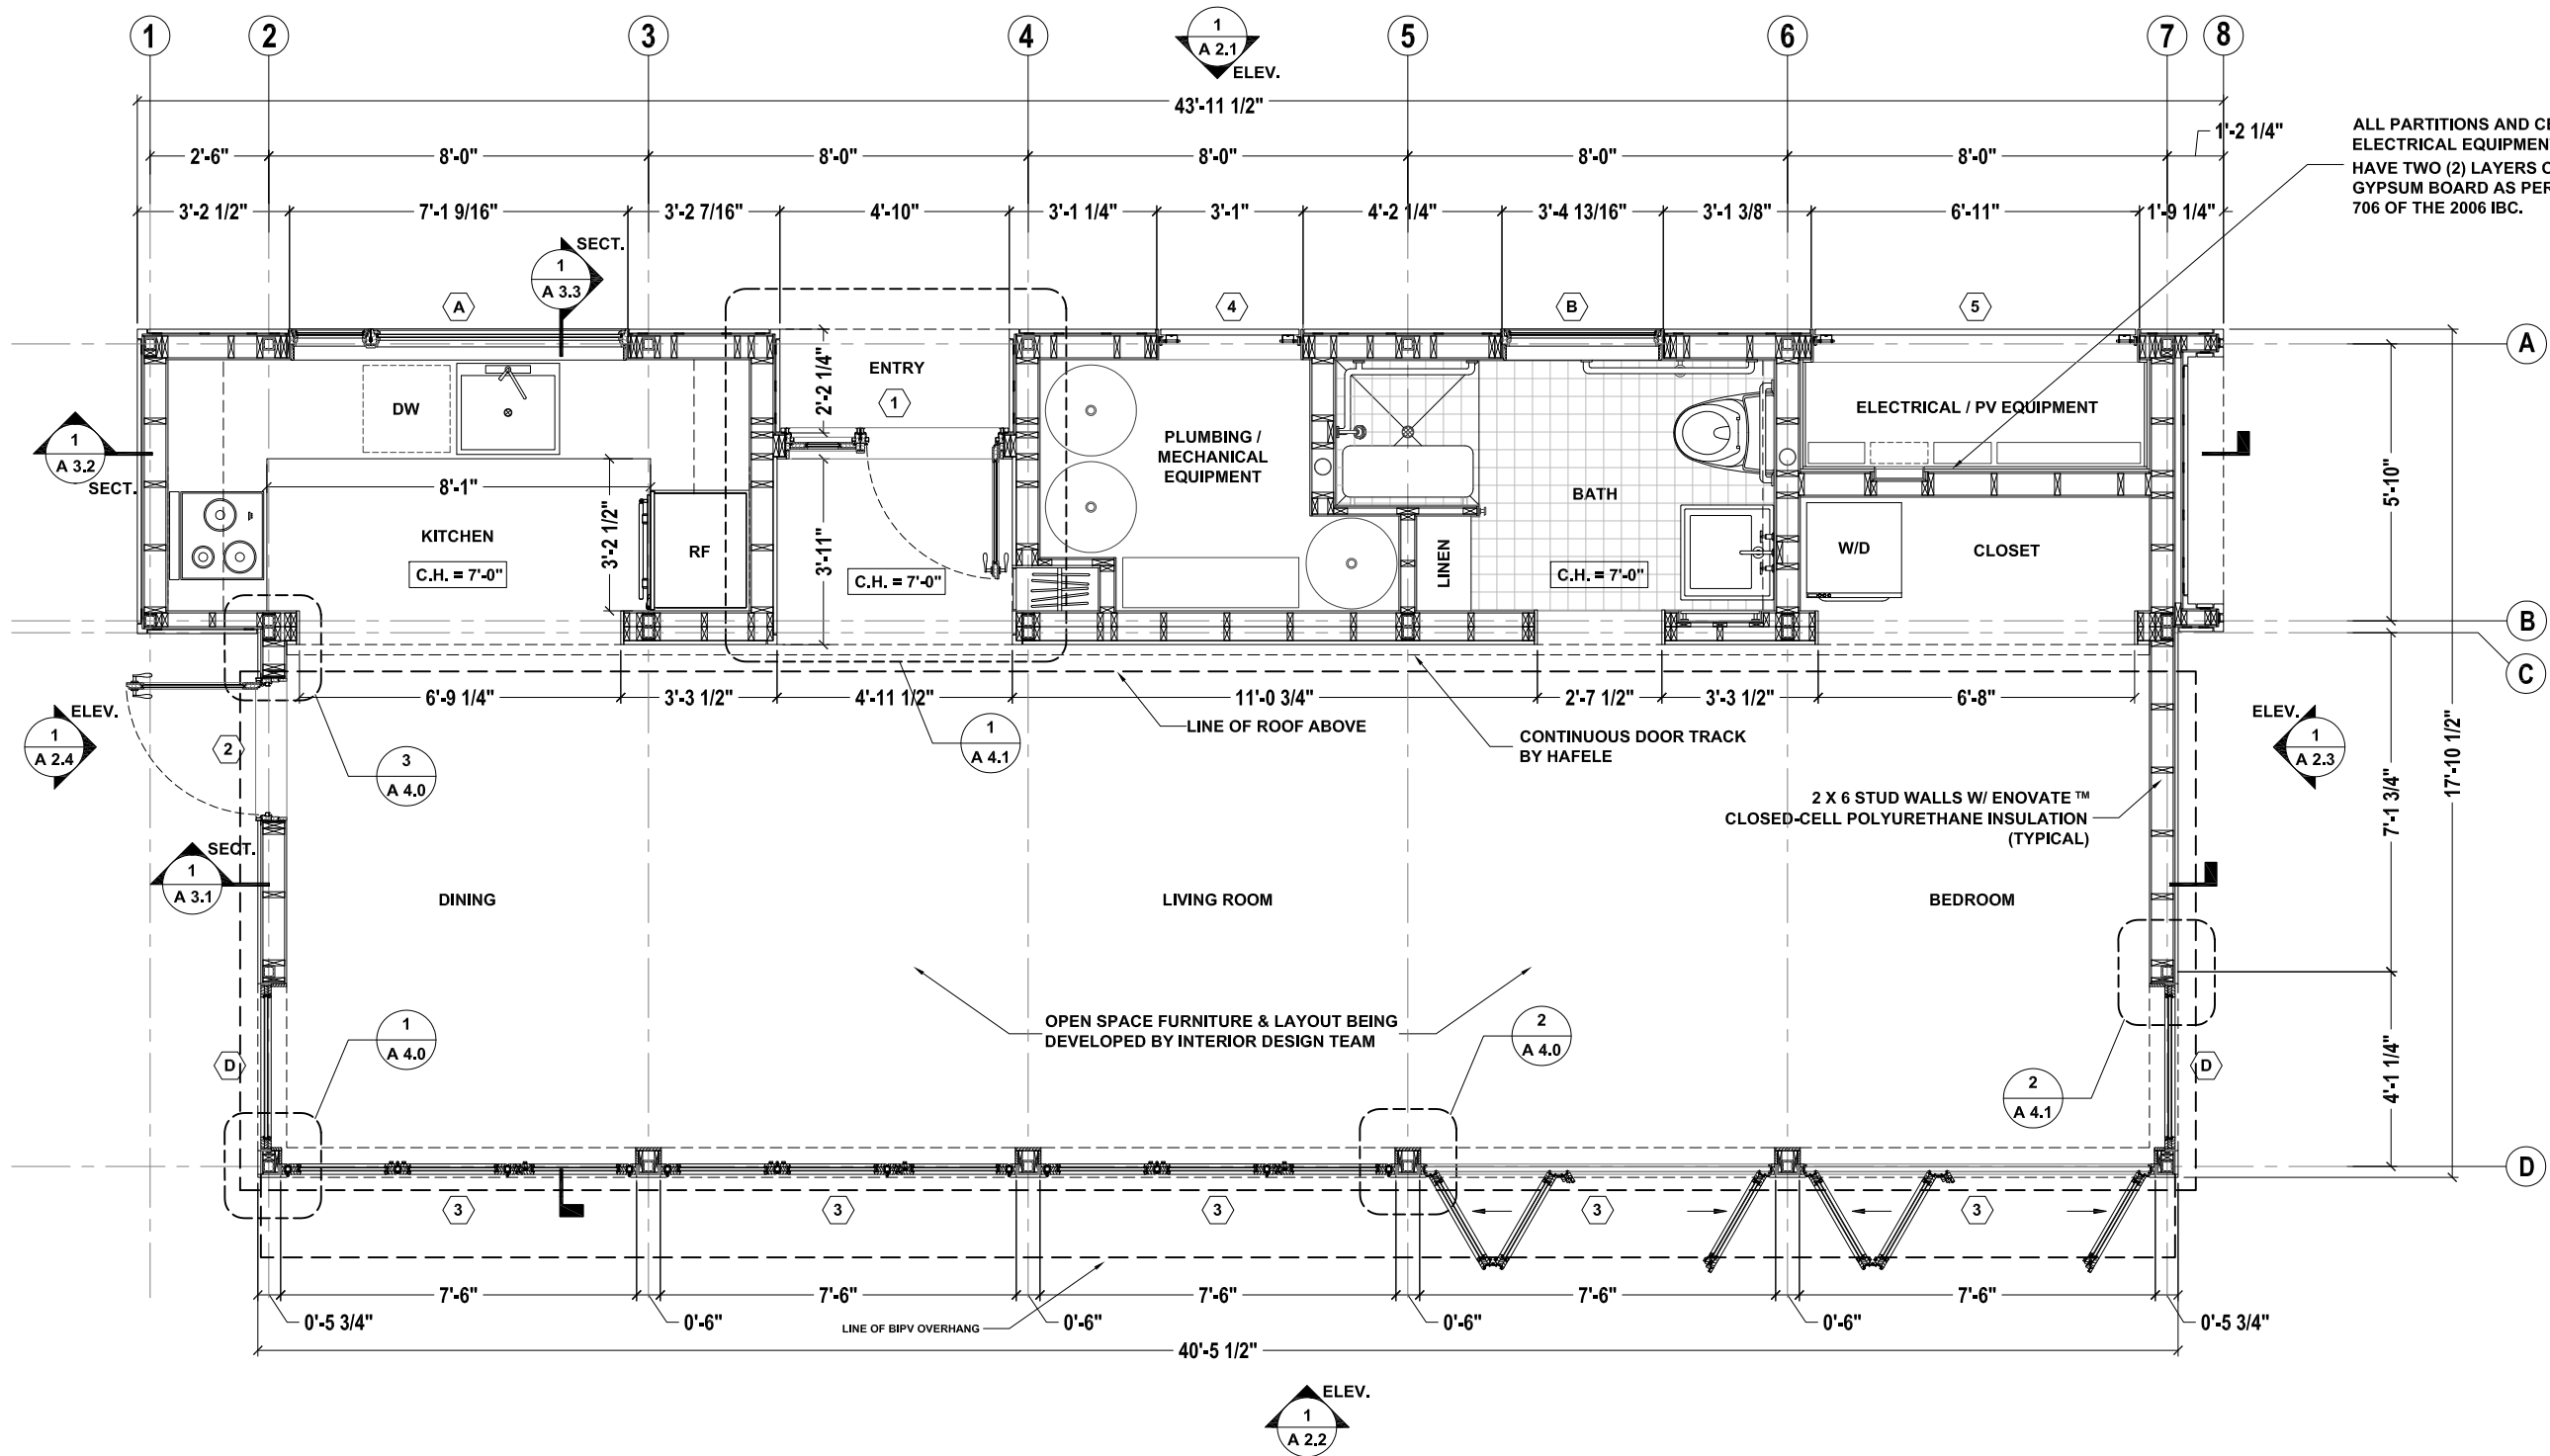

ALL PARTITIONS AND CEILING IN ELECTRICAL EQUIPMENT ROOM TO HAVE TWO (2) LAYERS OF 5/8" TYPE "X" GYPSUM BOARD AS PER SECTION 706 OF THE 2006 IBC.

**ARCHITECTURAL FLOOR PLAN**  
 SCALE 1/4" = 1'-0"  
 0 2' 4' 8'

## ARCHITECTURAL FLOOR PLAN

REVISIONS		Scale: 1/4" = 1' - 0"
No.	Date:	Description:
1	06.13.06	Design Development Drawings
2	03.06.07	Construction Drawings Rev. 1
3	08.07.07	Construction Drawings Rev. 2
Drawn By: MM		Checked By: MM
Date: August 7th, 2007		

DRAWING:

# A 1.1

SHEET: 9 of 66